


FILE: O:\GBCAD\PROJECTS\AEV753\01\STAGE 8\DRAWINGS\CIVIL\AEV753-01-DW-CV-GEN-8002.DWG DATE: Friday, 15 July 2022 4:51:32 PM Kelllogg Brown & Root

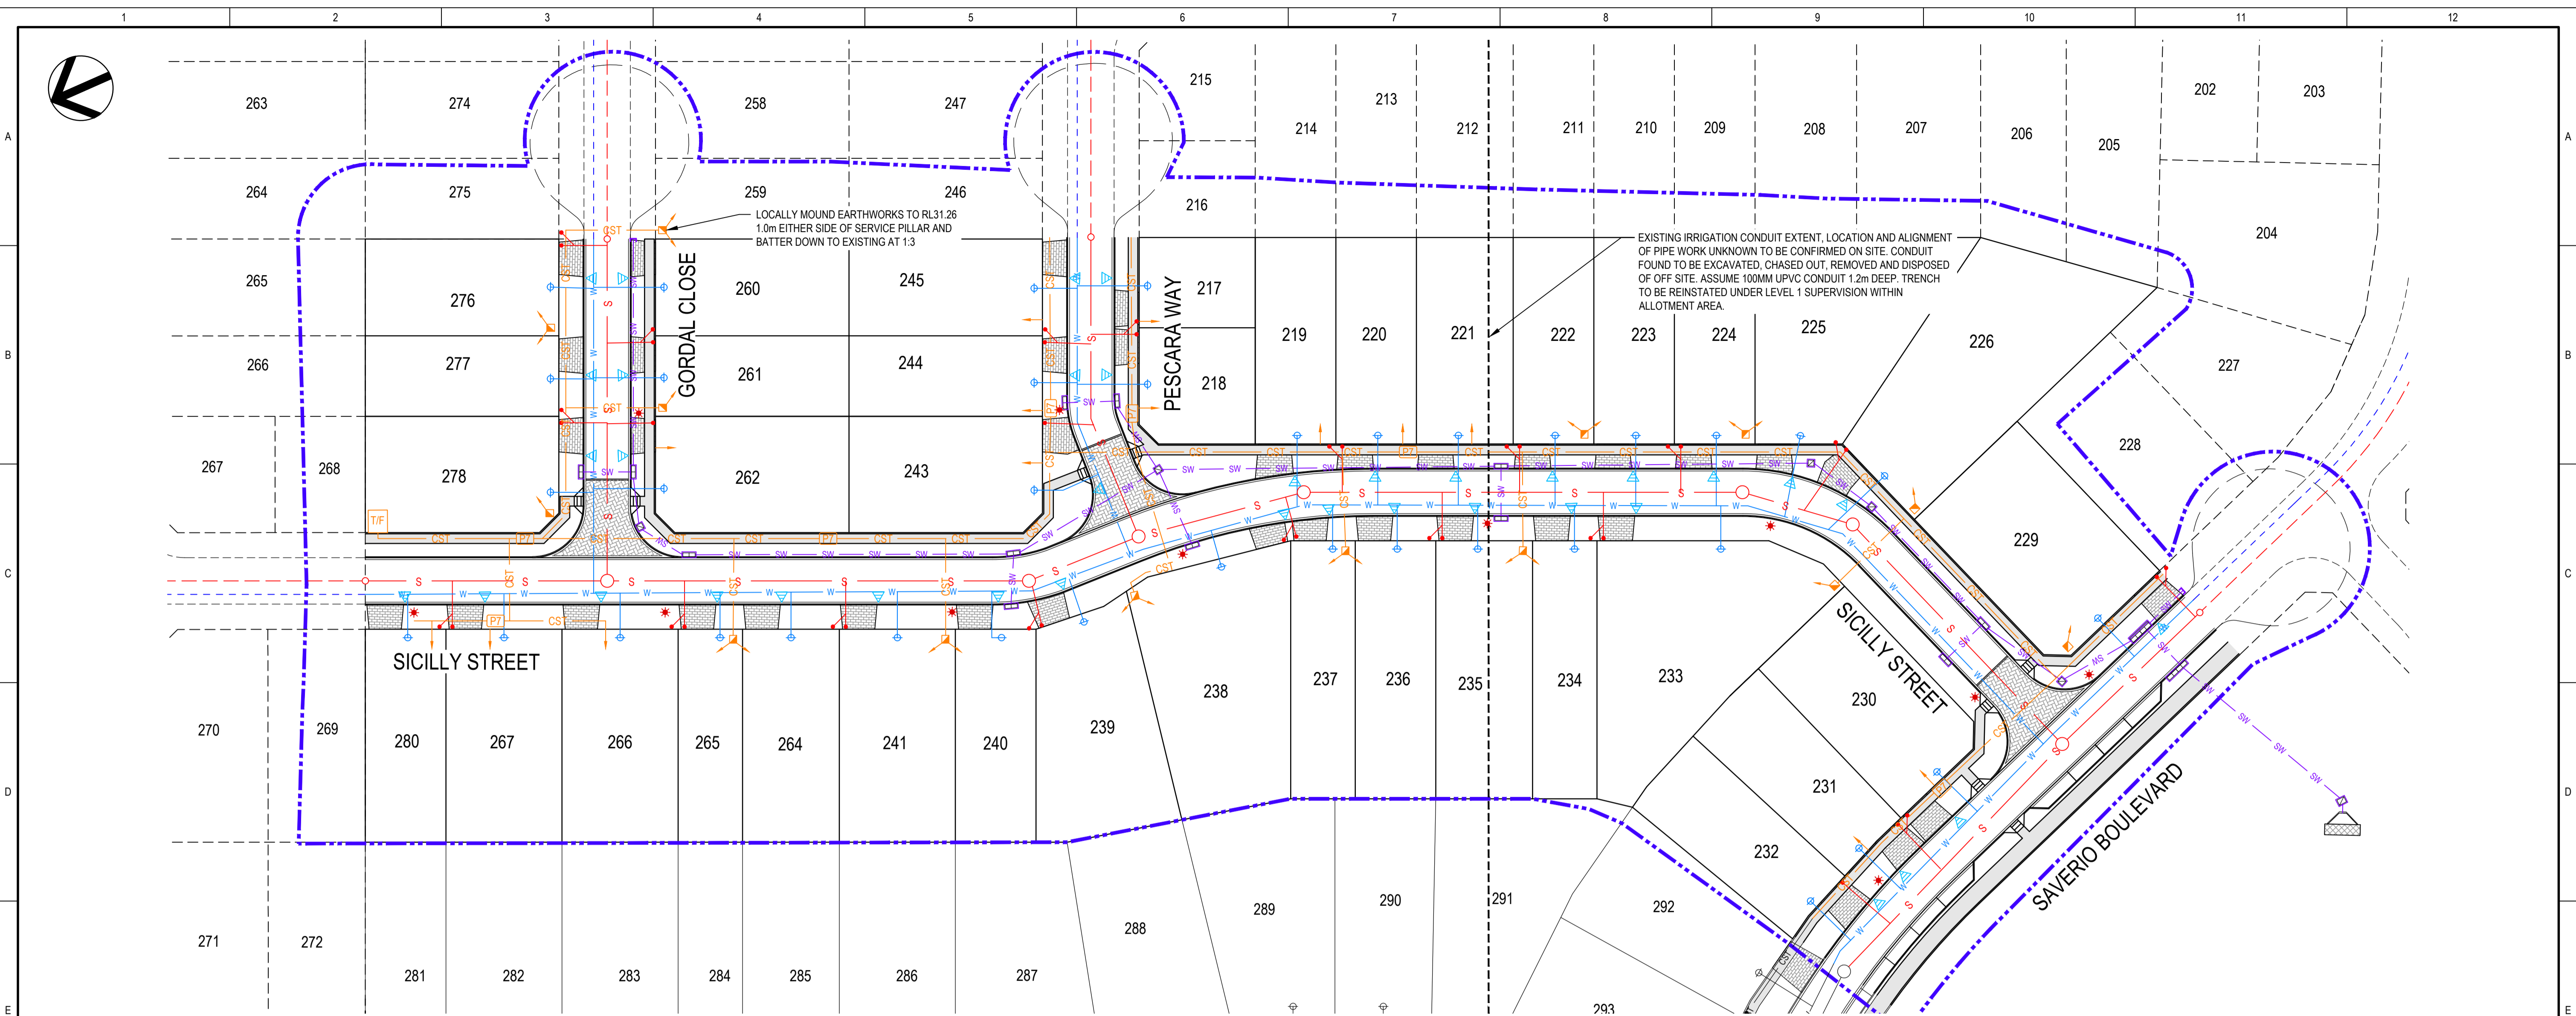

SERVICE LAYOUT PLAN
SCALE 1: 500

LEGEND

DESIGN SERVICES

- SW STORMWATER PIPES
- S SEWER MAIN
- W POTABLE WATER MAIN
- CST COMMON SERVICE TRENCH (REFER ELECTRICAL DRAWINGS)
- FUTURE STORMWATER PIPES
- FUTURE SEWER MAIN
- FUTURE POTABLE WATER MAIN
- NEW SEWER CONNECTION
- NEW SEWER MS
- NEW SEWER INSPECTION OPENING
- NEW SEWER MH
- POTABLE WATER SERVICE CONNECTIONS TO BE PLACED CENTRAL TO ALLOTMENT UNLESS SHOWN OTHERWISE REFER SA WATER DRAWINGS
- STORMWATER JUNCTION BOX
- STORMWATER DOUBLE SIDE ENTRY PIT
- STORMWATER HEADWALL
- HOUSE/STORMWATER DRAINAGE CONNECTION TO BE INSTALLED 0.2m FROM BOUNDARY ON LOW SIDE OF ALLOTMENT (TYPICAL) REFER TO DETAIL ON DRAWING AEV753-01-DW-CV-GEN-8013

- PROPOSED ELECTRICAL PILLAR
- PROPOSED ELECTRICAL CONSUMER MAIN LEAD-IN
- PROPOSED LIGHTPOLE LOCATION
- PROPOSED ELECTRICAL PIT
- PRAM RAMP, TGS's & DETAILS AS PER COUNCIL PRAM RAMP DETAIL. (TACTILE INDICATORS NOT SHOWN ON THIS DRAWING FOR CLARITY)
- DRIVEWAY (BY OTHERS)
- FOOTPATH
- BLOCK PAVED ROAD
- EXTENT OF WORKS

EXISTING SERVICES


- S EXISTING SEWER MAIN
- w EXISTING POTABLE WATER
- CST EXISTING ELECTRICAL
- EXISTING SEWER MH
- ◇ EXISTING POTABLE WATER SERVICE

NOTE:

- ELECTRICAL LAYOUT SHOWN INDICATIVELY ONLY. REFER TO ELECTRICAL DRAWINGS FOR COMMON SERVICES TRENCH AND ELECTRICAL RETICULATION LAYOUT.

FOR CONSTRUCTION

REV	DESCRIPTION	DATE	POSITION	NAME	SIGNATURE
	DRAFTING CHECK		A. TEAKLE	A.T.	
	ORIGINATE/DESIGN		S. HUTTON	S.H.	
	INDEPENDENT CHECK		B. CHUA	B.C.	
	TECHNICAL APPROVAL		M. PAGE	M.P.	
	PROJECT APPROVAL		M. PAGE	M.P.	
0	ISSUED FOR CONSTRUCTION	17.03.22			

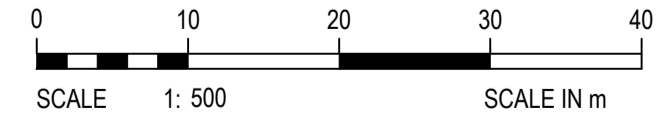

TITLE
**LANSER COMMUNITIES
 ANGLE VALE
 NOTO STAGE 8
 SERVICES LAYOUT PLAN**

DRAWING SCALE
1:500
 DRAFTER: MB

ORIG. SIZE
A1

DRAWING No.
AEV753-001-DW-CV-GEN-8002

REVISION
0