



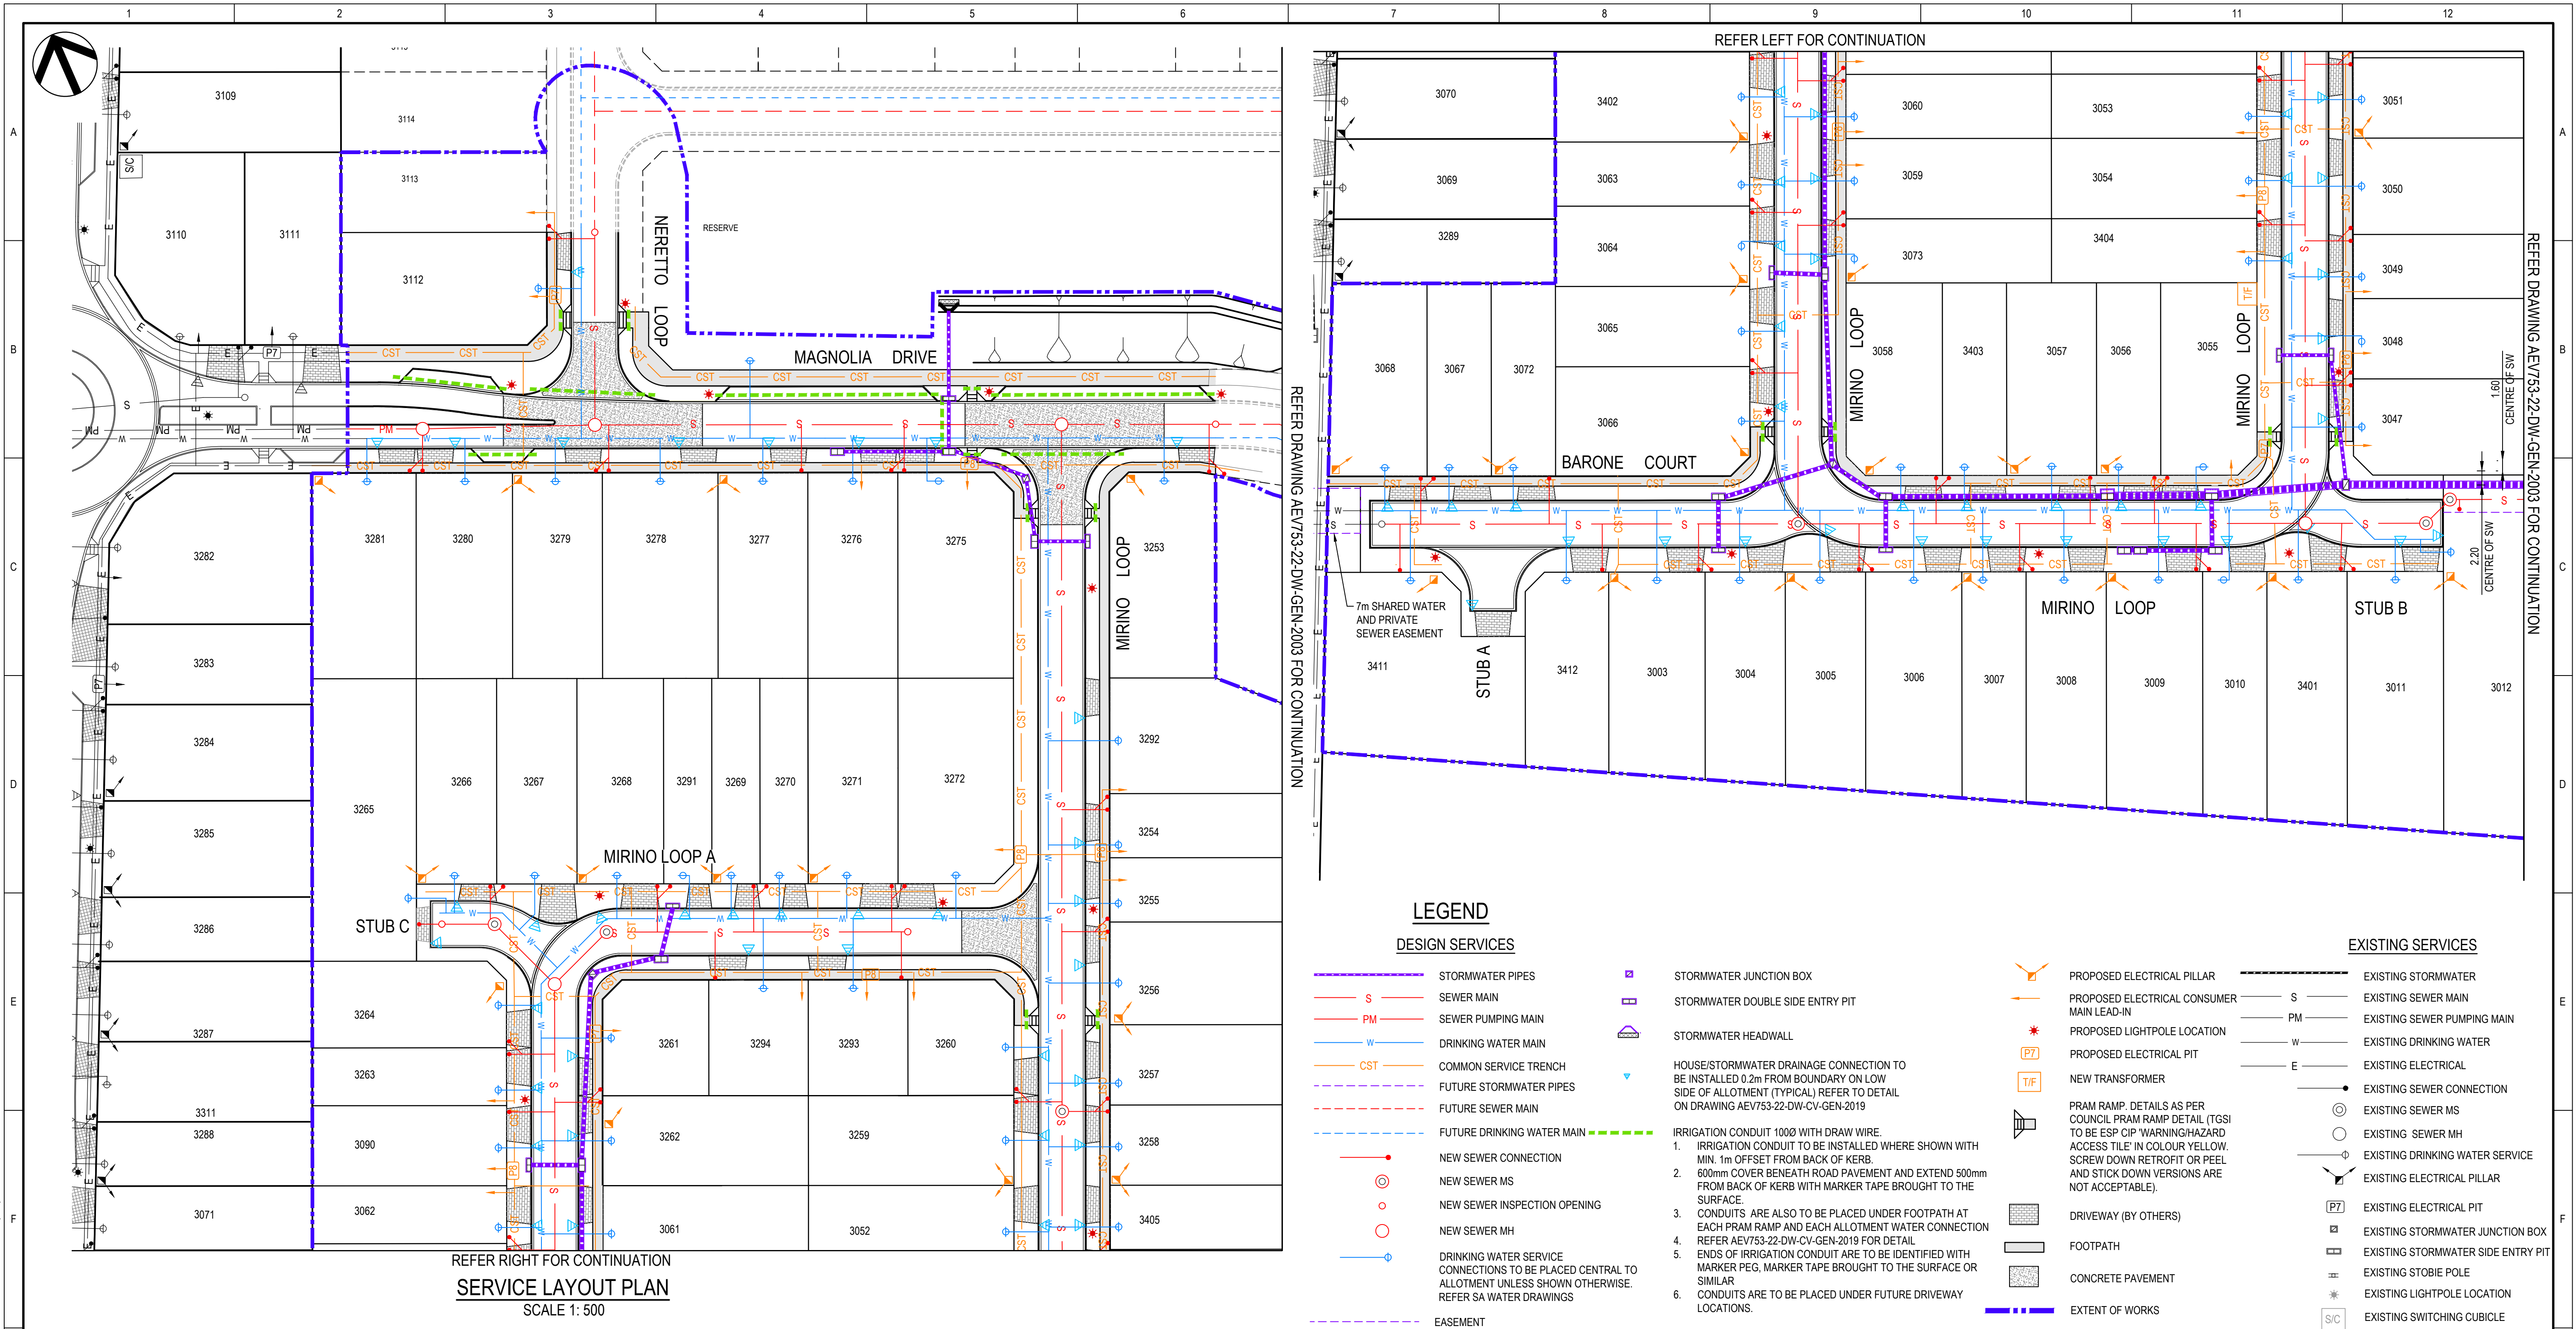

NOTE:

- ELECTRICAL LAYOUT SHOWN INDICATIVELY ONLY. REFER TO ELECTRICAL DRAWINGS FOR COMMON SERVICES TRENCH AND ELECTRICAL RETICULATION LAYOUT.

REV	DESCRIPTION	DATE	POSITION	NAME	SIGNATURE
			DRAFTING CHECK	R. MALLEN	
			ORIGINATE/ DESIGN	J. GROSSER	
			INDEPENDENT CHECK	M. PAGE	
			TECHNICAL APPROVAL	J. GROSSER	
			PROJECT APPROVAL	J. GROSSER	
			CLIENT APPROVAL		
0	ISSUED FOR CONSTRUCTION	20.05.25			

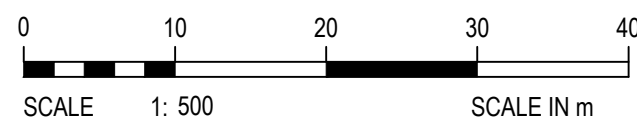

TITLE
LANSER COMMUNITIES
ANGLE VALE
MIRVALE EAST STAGE 2
SERVICES LAYOUT PLAN 1 OF 2

DRAWING SCALE
1:500;
DRAFTER: MB

ORIG. SIZE
A1

DRAWING No.
AEV753-22-DW-CV-GEN-2002

REVISION
0

FOR CONSTRUCTION